



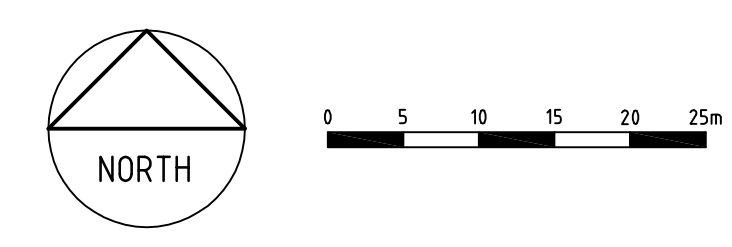

- LEGEND**
- SPORTS LIGHTS - POLE MOUNTED, QUANTITY AS INDICATED. (REFER TO TYPICAL DETAIL). POLES SHALL BE LOCATED A MINIMUM OF 5m AWAY FROM PLAYING FIELD.
 - POWER PIT - ACO CABLE MATE - TYPE 45 POLYMER CONCRETE WITH GALVANISED STEEL POWERLOK LID.
 - SITE MAIN SWITCHBOARD
 - UNDERGROUND POWER CONDUIT

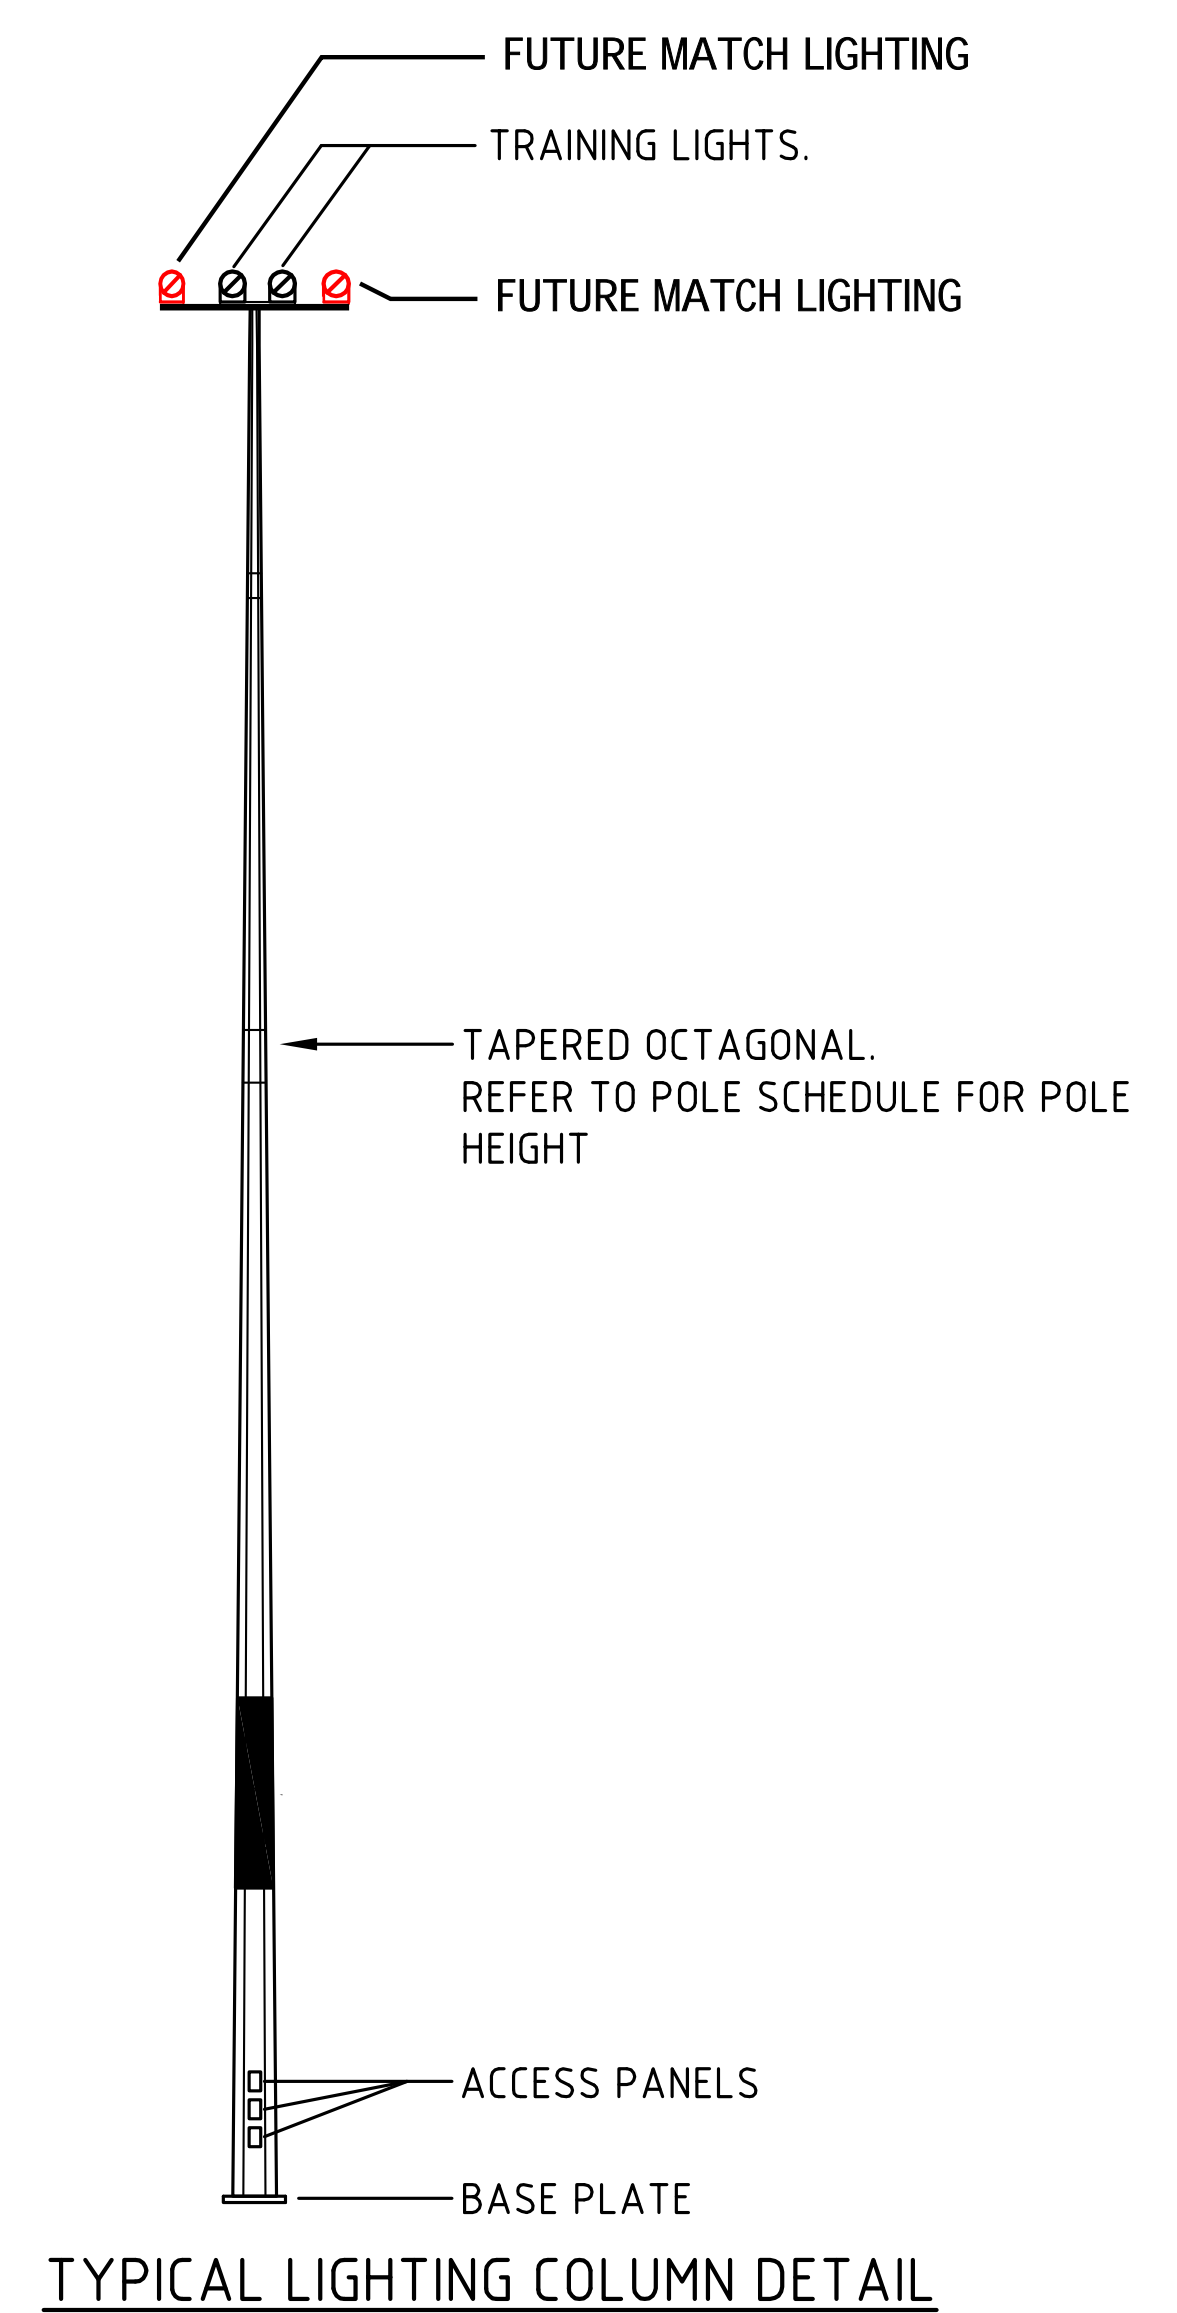

CITY OF WANNEROO
INFRASTRUCTURE

BEST Consultants
BUILDING ENGINEERING SERVICES + TECHNOLOGY
575 NEWCASTLE ST. WEST PERTH, 6005
E: info@bestconsultants.com.au
T: +61 8 9227 0500
www.bestconsultants.com.au
BEST REF: 1819.033

HAINSWORTH PARK
OVAL FLOODLIGHTING
GIRRAWHEEN

SITE PLAN
SHEET 1 OF 1

DRAWING No. SHEET REVISION ORIGINAL DRG. SIZE
E001-1-A A1

FILE No. PROJECT No. 1819.033

No.	REVISION	BY	DATE	AUTH	No.	REVISION	BY	DATE	AUTH
1	ISSUED FOR REVIEW	LB	02/20/11						

SCALE: 1:500
SCALE IN METRES
5 0 5 10 15 20 25
DATE: AHD
GRID: MG94

DESIGNER: LBRANDS
CONSULTANT: BEST CONSULTANTS
DRAWN: LBRANDS
CONSULTANT: BEST CONSULTANTS

CHECKED: JROMANO
CERTIFICATION: JROMANO
CONSULTANT: BEST CONSULTANTS

QUALITY ASSURANCE: JROMANO
APPROVED: JROMANO
CONSULTANT: BEST CONSULTANTS