



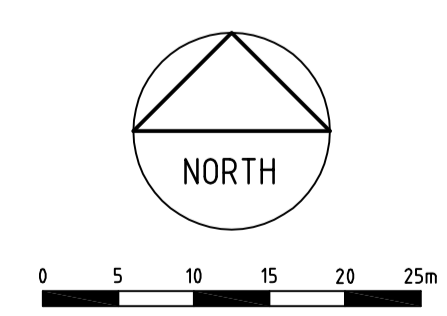

- LEGEND**
- SPORTS LIGHTS - POLE MOUNTED, QUANTITY AS INDICATED. (REFER TO TYPICAL DETAIL). POLES SHALL BE LOCATED A MINIMUM OF 5m AWAY FROM PLAYING FIELD.
  - POWER PIT - ACO CABLE MATE - TYPE 45 POLYMER CONCRETE WITH GALVANISED STEEL POWERLOK LID.
  - SMSB - SITE MAIN SWITCHBOARD
  - UNDERGROUND POWER CONDUIT

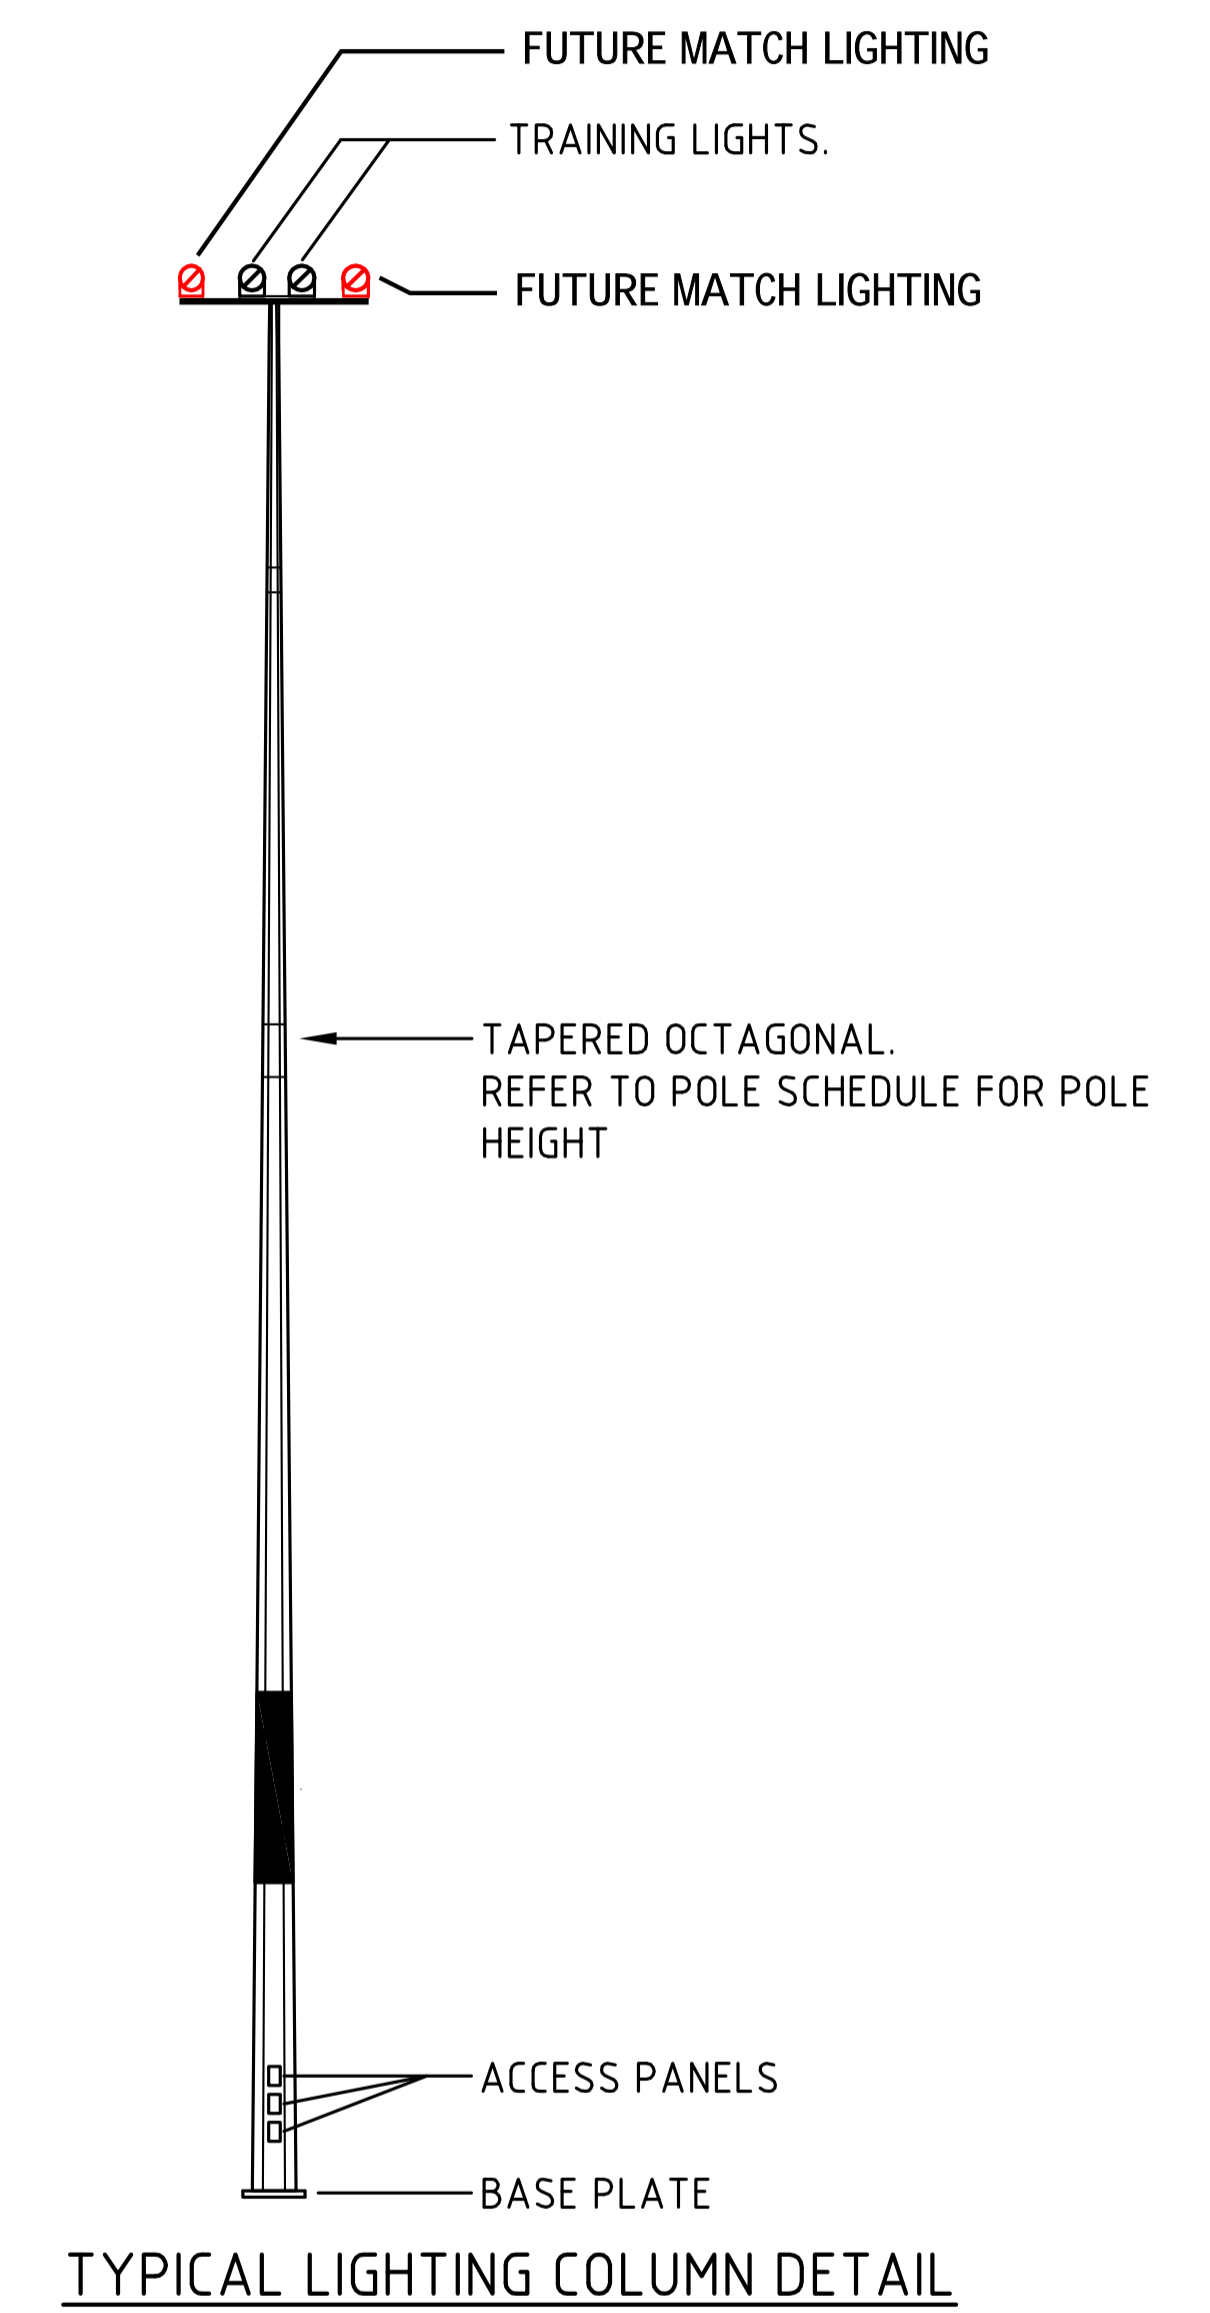

**CITY OF WANNEROO**  
INFRASTRUCTURE

**BEST Consultants**  
BUILDING ENGINEERING SERVICES + TECHNOLOGY  
575 NEWCASTLE ST. WEST PERTH, 6005  
E: info@bestconsultants.com.au  
T: +61 8 9227 0500  
www.bestconsultants.com.au  
BEST REF: 1819.033

**KOONDOOLA PARK**  
OVAL FLOODLIGHTING

KOONDOOLA

SITE PLAN  
SHEET 1 OF 1

No.	REVISION	BY	DATE	AUTH	No.	REVISION	BY	DATE	AUTH
1	ISSUED FOR REVIEW	L.B.	02/20/11						

No.	REVISION	BY	DATE	AUTH	No.	REVISION	BY	DATE	AUTH

SCALE: 1:500  
SCALE IN METRES  
0 5 10 15 20 25  
D.A.H. M.C.S.94

DESIGNED: L.BRANDS  
CONSULTANT: BEST CONSULTANTS  
DRAWN: L.BRANDS  
CONSULTANT: BEST CONSULTANTS

CHECKED: J.ROMANO  
CONSULTANT: BEST CONSULTANTS  
CERTIFICATION: J.ROMANO  
CONSULTANT: BEST CONSULTANTS

QUALITY ASSURANCE: J.ROMANO  
CONSULTANT: BEST CONSULTANTS  
APPROVED: J.ROMANO  
CONSULTANT: BEST CONSULTANTS

FILE No. -  
PROJECT No. 1819.033

DRAWING No.	SHEET	REVISION	ORIGINAL DRG. SIZE
<b>E100-1-A</b>			<b>A1</b>