








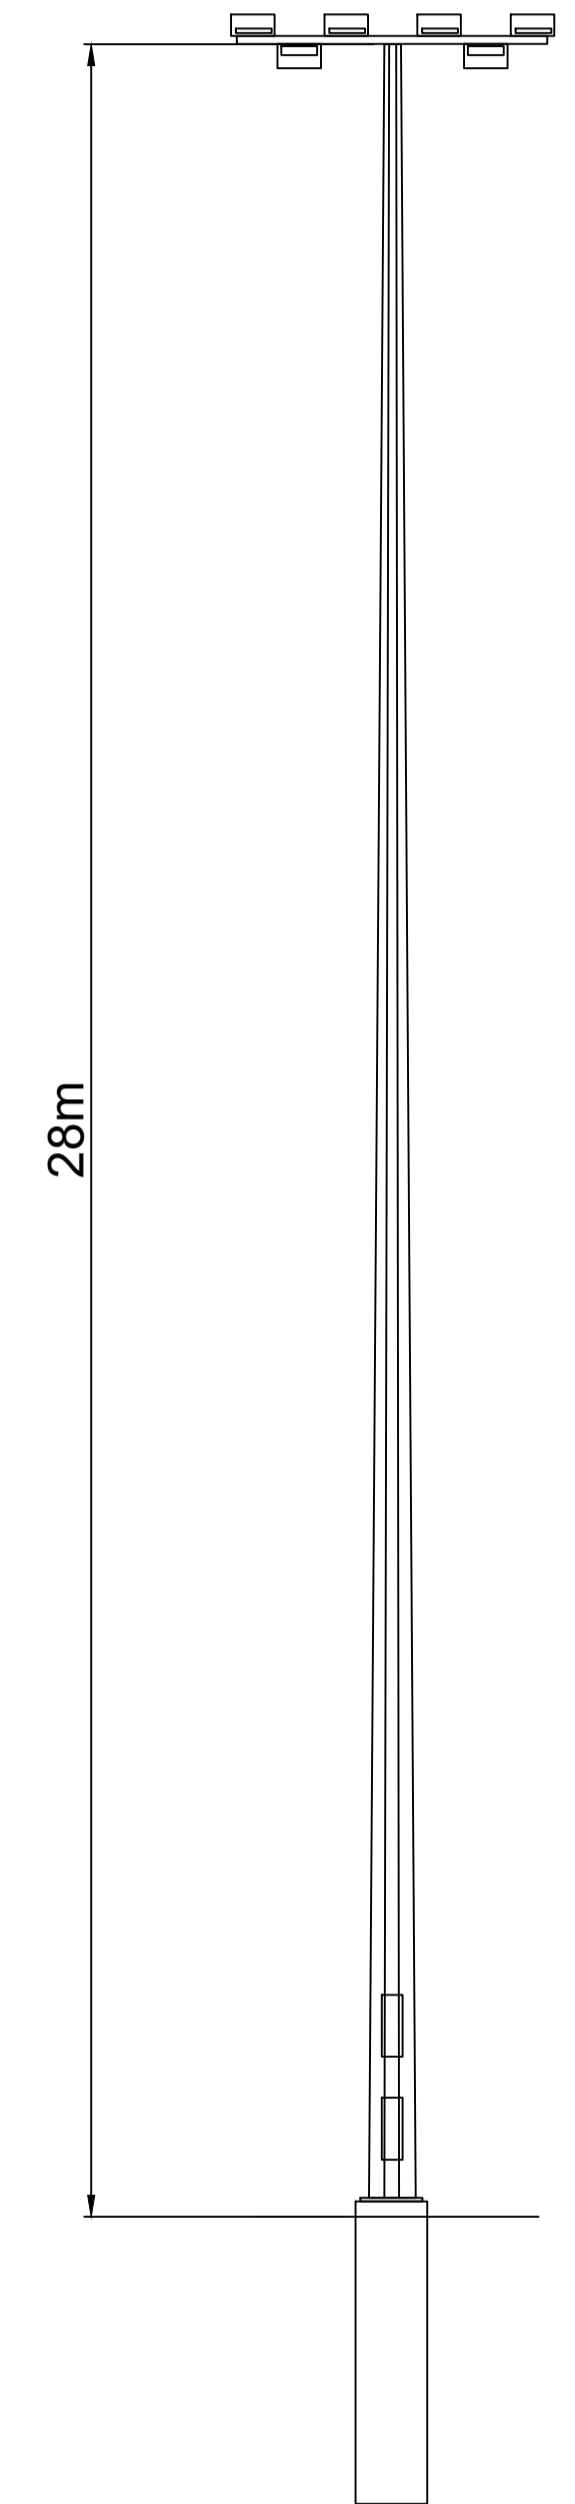
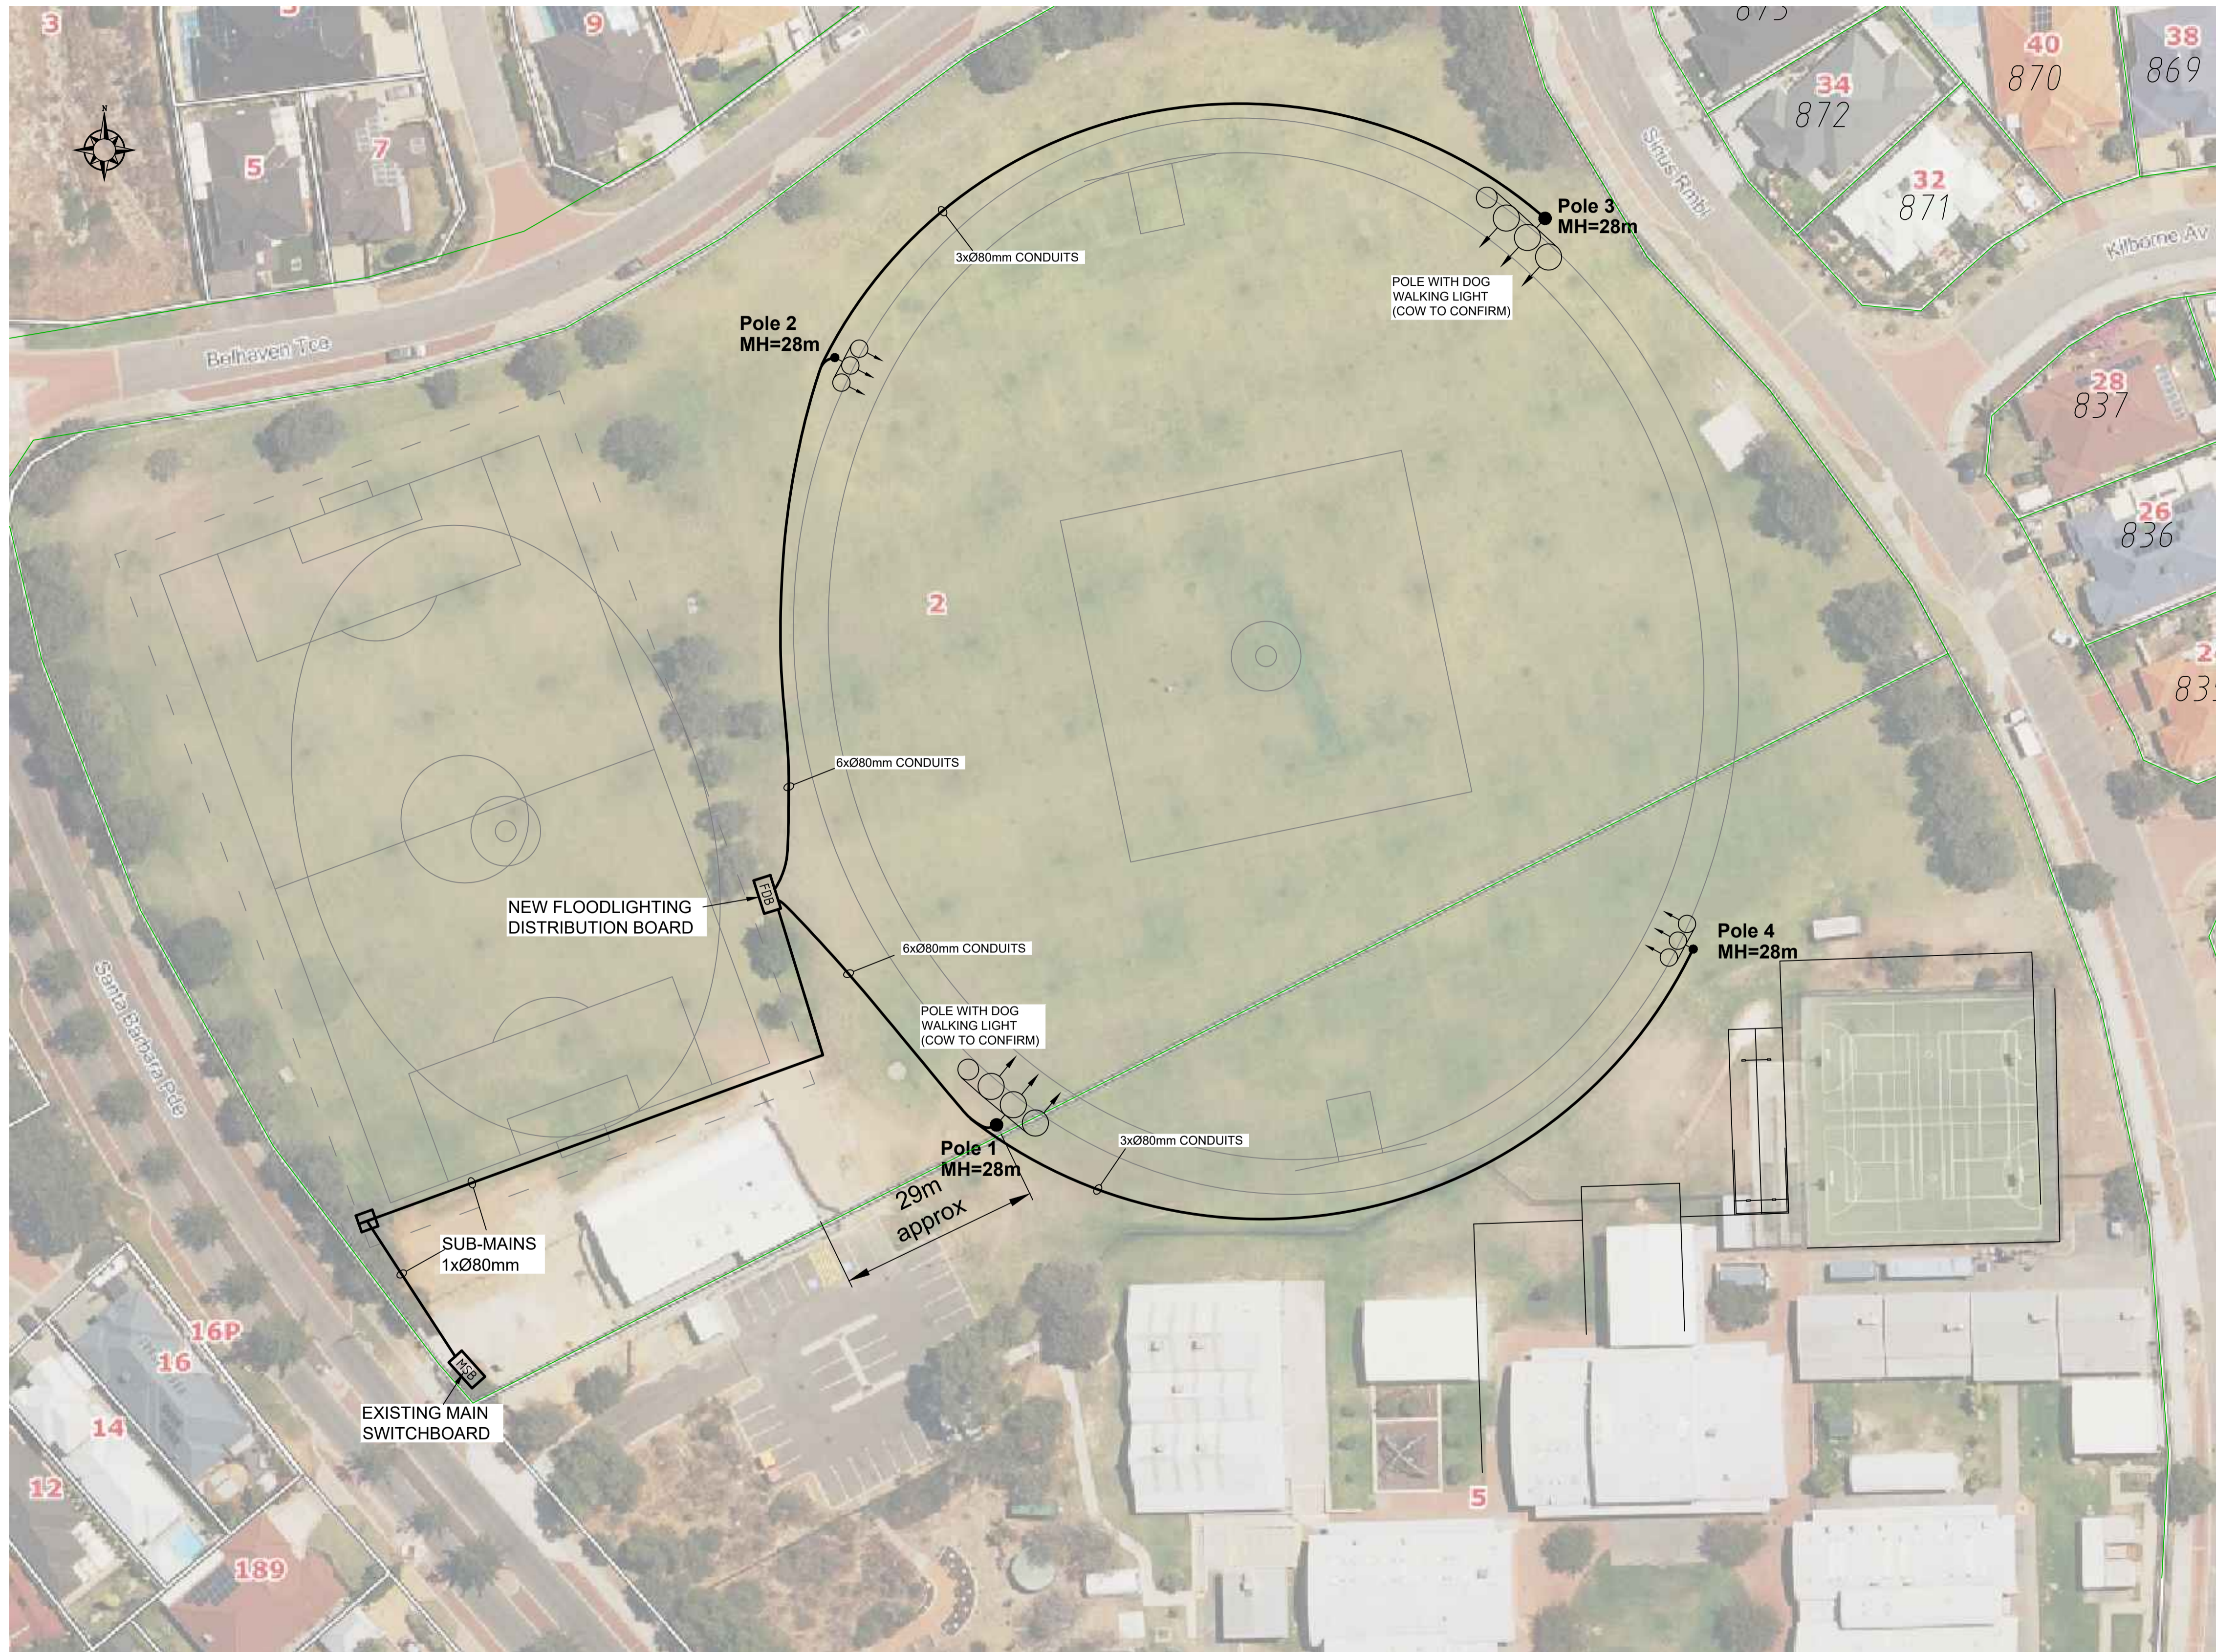
0 5000 10000 20000 30000
 Full Size 1:500; Half Reduction 1:1000
 SCALE (mm)

NOTES:

- MACHINE TRENCHING IN THE VICINITY OF THE TREE DRIP LINES IS PROHIBITED. HAND TRENCHING REQUIRED WITH CARE. ALTERNATIVE ROUTES TO BE AGREED ON WITH CONSULTATION WITH THE CITY.

LEGEND

-  FLOODLIGHTING DISTRIBUTION BOARD (NEW)
-  MAIN SWITCHBOARD (EXISTING)
-  ACO 66 CABLE PIT
-  CABLE/CONDUIT ROUTE
-  FLOODLIGHTING POLE
-  SPORTS LIGHTING FLOODLIGHT
-  DOG WALKING LIGHT



CITY OF WANNEROO
ASSETS

BELHAVEN PARK,
 QUINNS ROCKS
 FLOODLIGHTING ELECTRICAL SERVICES
 LOCALITY

SITE PLAN
 SHEET 1 OF 4

No.	REVISION	BY	DATE	AUTH	No.	REVISION	BY	DATE	AUTH	SCALE:	SURVEYED:	DESIGNED:	CHECKED:	APPROVED:	FINANCE CODE	FMD No.	DRAWING No.	SHEET	REVISION	ORIGINAL Dwg. SIZE
A	ISSUED FOR CLIENT REVIEW	IA	29/1/21	IA						SCALE: 1:500	X/XXXX SUPERVISOR /2018	X/XXXX CIVIL DESIGNER /2018	X/XXXX P. WILLIAMS COORDINATOR DESIGN /2018	L. NICHOLSON MANAGER: INFRASTRUCTURE CAPITAL WORKS /2018	PR-0000	00000	3969-1-A	1		A1
										DATUM: LOCAL	GRID: LOCAL	X/XXXX CIVIL DESIGNER /2018	X/XXXX CIVIL DESIGNER /2018	APPROVED: DIRECTOR ASSETS	DRAWING SET REF 00/00000	FMD CONTAINER No. 00000				