



LIGHT POLE COORDINATES		
POLE	EASTING	NORTHING
POLE 1	32916.922	309112.803
POLE 2	32978.663	309011.849
POLE 3	32850.364	308927.201
POLE 4	32793.031	309035.854

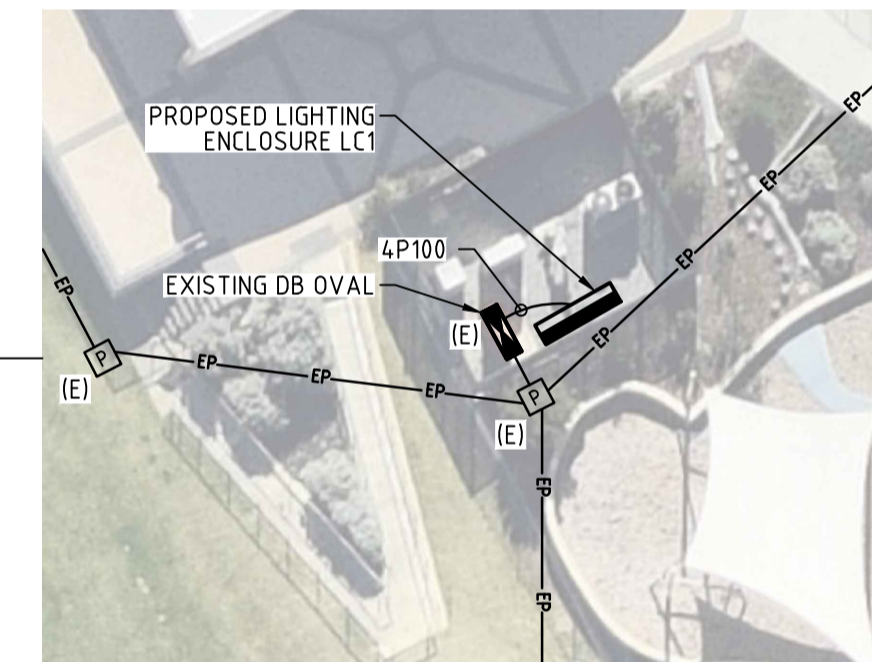

COMPOUND LAYOUT FOR CLARITY
SCALE 1:250

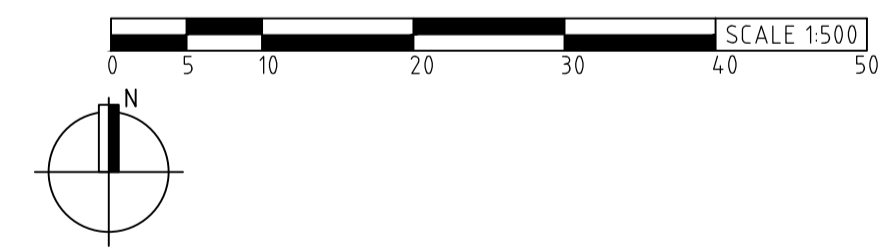

FOCUS CONSULTING WA
PO BOX 130, LEEDERVILLE WA 6007
PRD.J. No. 2021-273
E: info@focuswa.com.au
www.focuswa.com.au

CITY OF WANNEROO
ASSETS

SPLENDID PARK
SPLENDID AVENUE
SPORTS LIGHTING RENEWAL
YANCHEP

AFL OVAL SPORTS LIGHTING LAYOUT
SHEET 2 OF 7

No.	REVISION	BY	DATE	AUTH	No.	REVISION	BY	DATE	AUTH	SCALE:	DATE:	DESIGNED:	DRAWN:	AUTHORISED:	MANAGER:	MANAGER:	FINANCE CODE:	PMO No.:	DRAWING No.:	SHEET	REVISION	ORIGINAL DRG. SIZE	
		PRJ	16/06/22							1:500 @ A1		X.XXXX	X.XXXX				PR-4271	20049					
		PRJ	28/07/22							LOCAL		X.XXXX	X.XXXX					40569*					
										MGA/20 - 50		X.XXXX	X.XXXX										

3944-02-E02 1 **A1**